




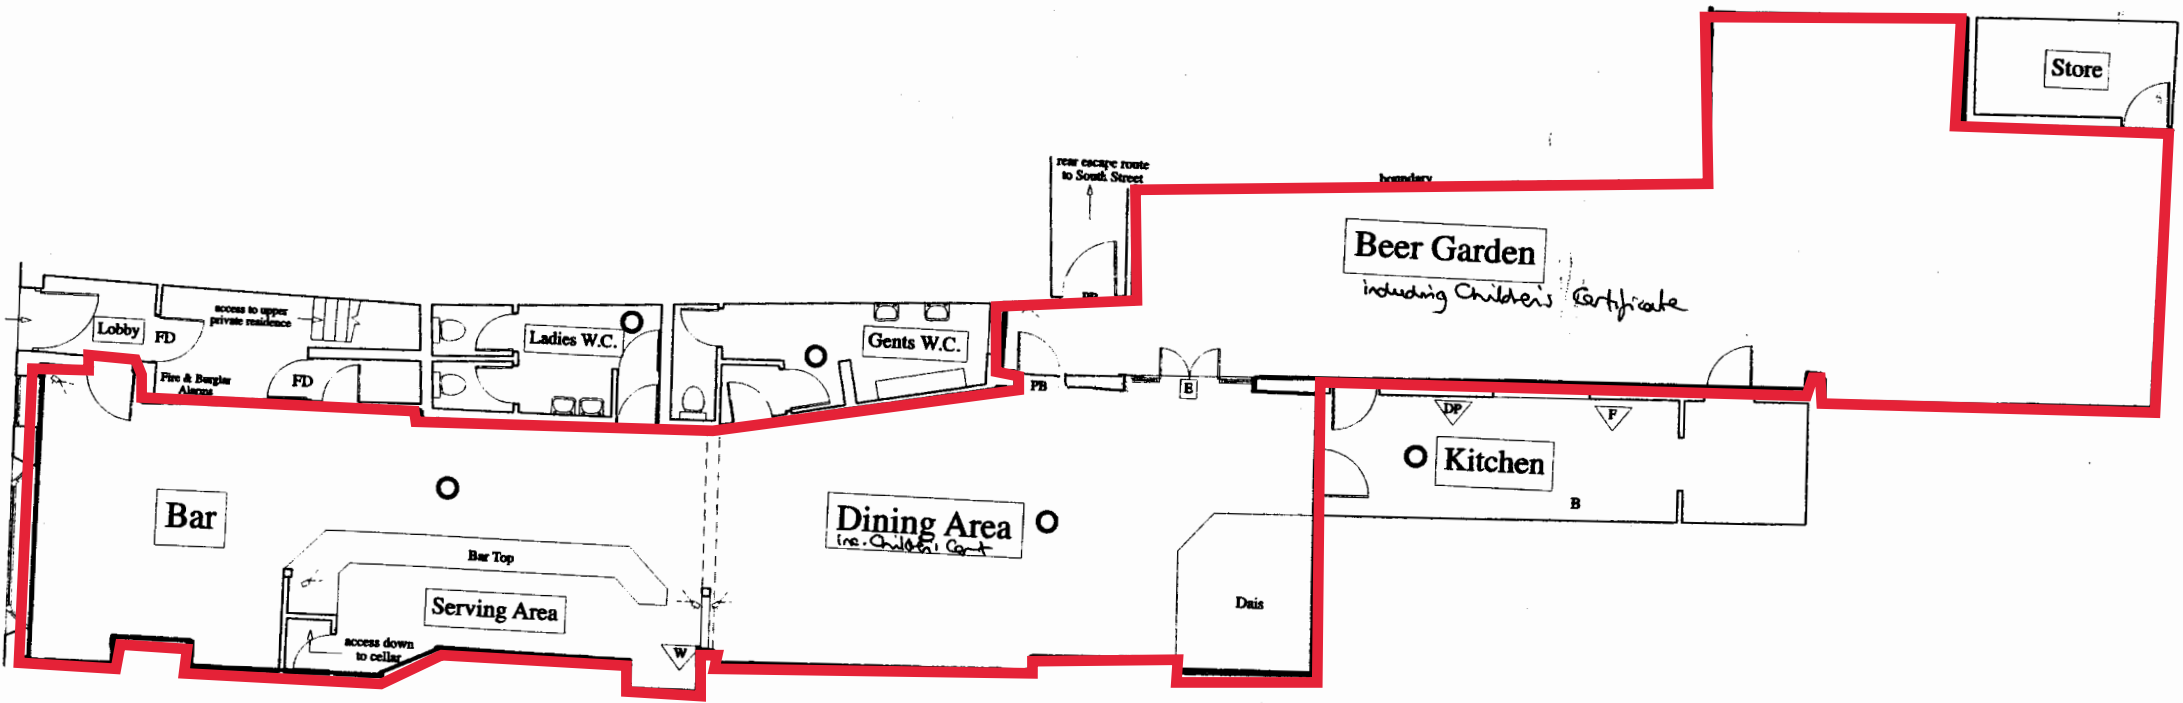


-  Fire Extinguisher - Foam Type
-  Fire Extinguisher - Water Type
-  Emergency Lighting Point
-  Emergency Fire Exit Sign
-  C.C.T.V. camera



**The Ducking Stool, South Street,
Leominster.**
GROUND FLOOR PLAN
Scale 1:100
New
Leominster