



WEST MERCIA POLICE REPRESENTATION – TRILOGY

21.08.2024

I am an officer authorised under the Licensing Act 2003.

I refer to the application made for a Grant of a premises licence in respect of Trilogy

West Mercia Police do not object to this application, however they have the following representations to promote the licensing objectives and wish to see them applied to any premises licence granted to this location.


Prevention of Crime & Disorder

The premises use pet glassware for wines, spirits and draught beer throughout the premises, except the Botanic bar (area shaded in yellow on the plan submitted 20/08/2024) where glass vessels can be used up to 0100hrs


Licensing and MATES Officer (Herefordshire) Hereford Police Station, Bath Street, Hereford
HR1 2HT

Email – licensing.herefordshire@westmercia.police.uk

PLAN AS EXISTING

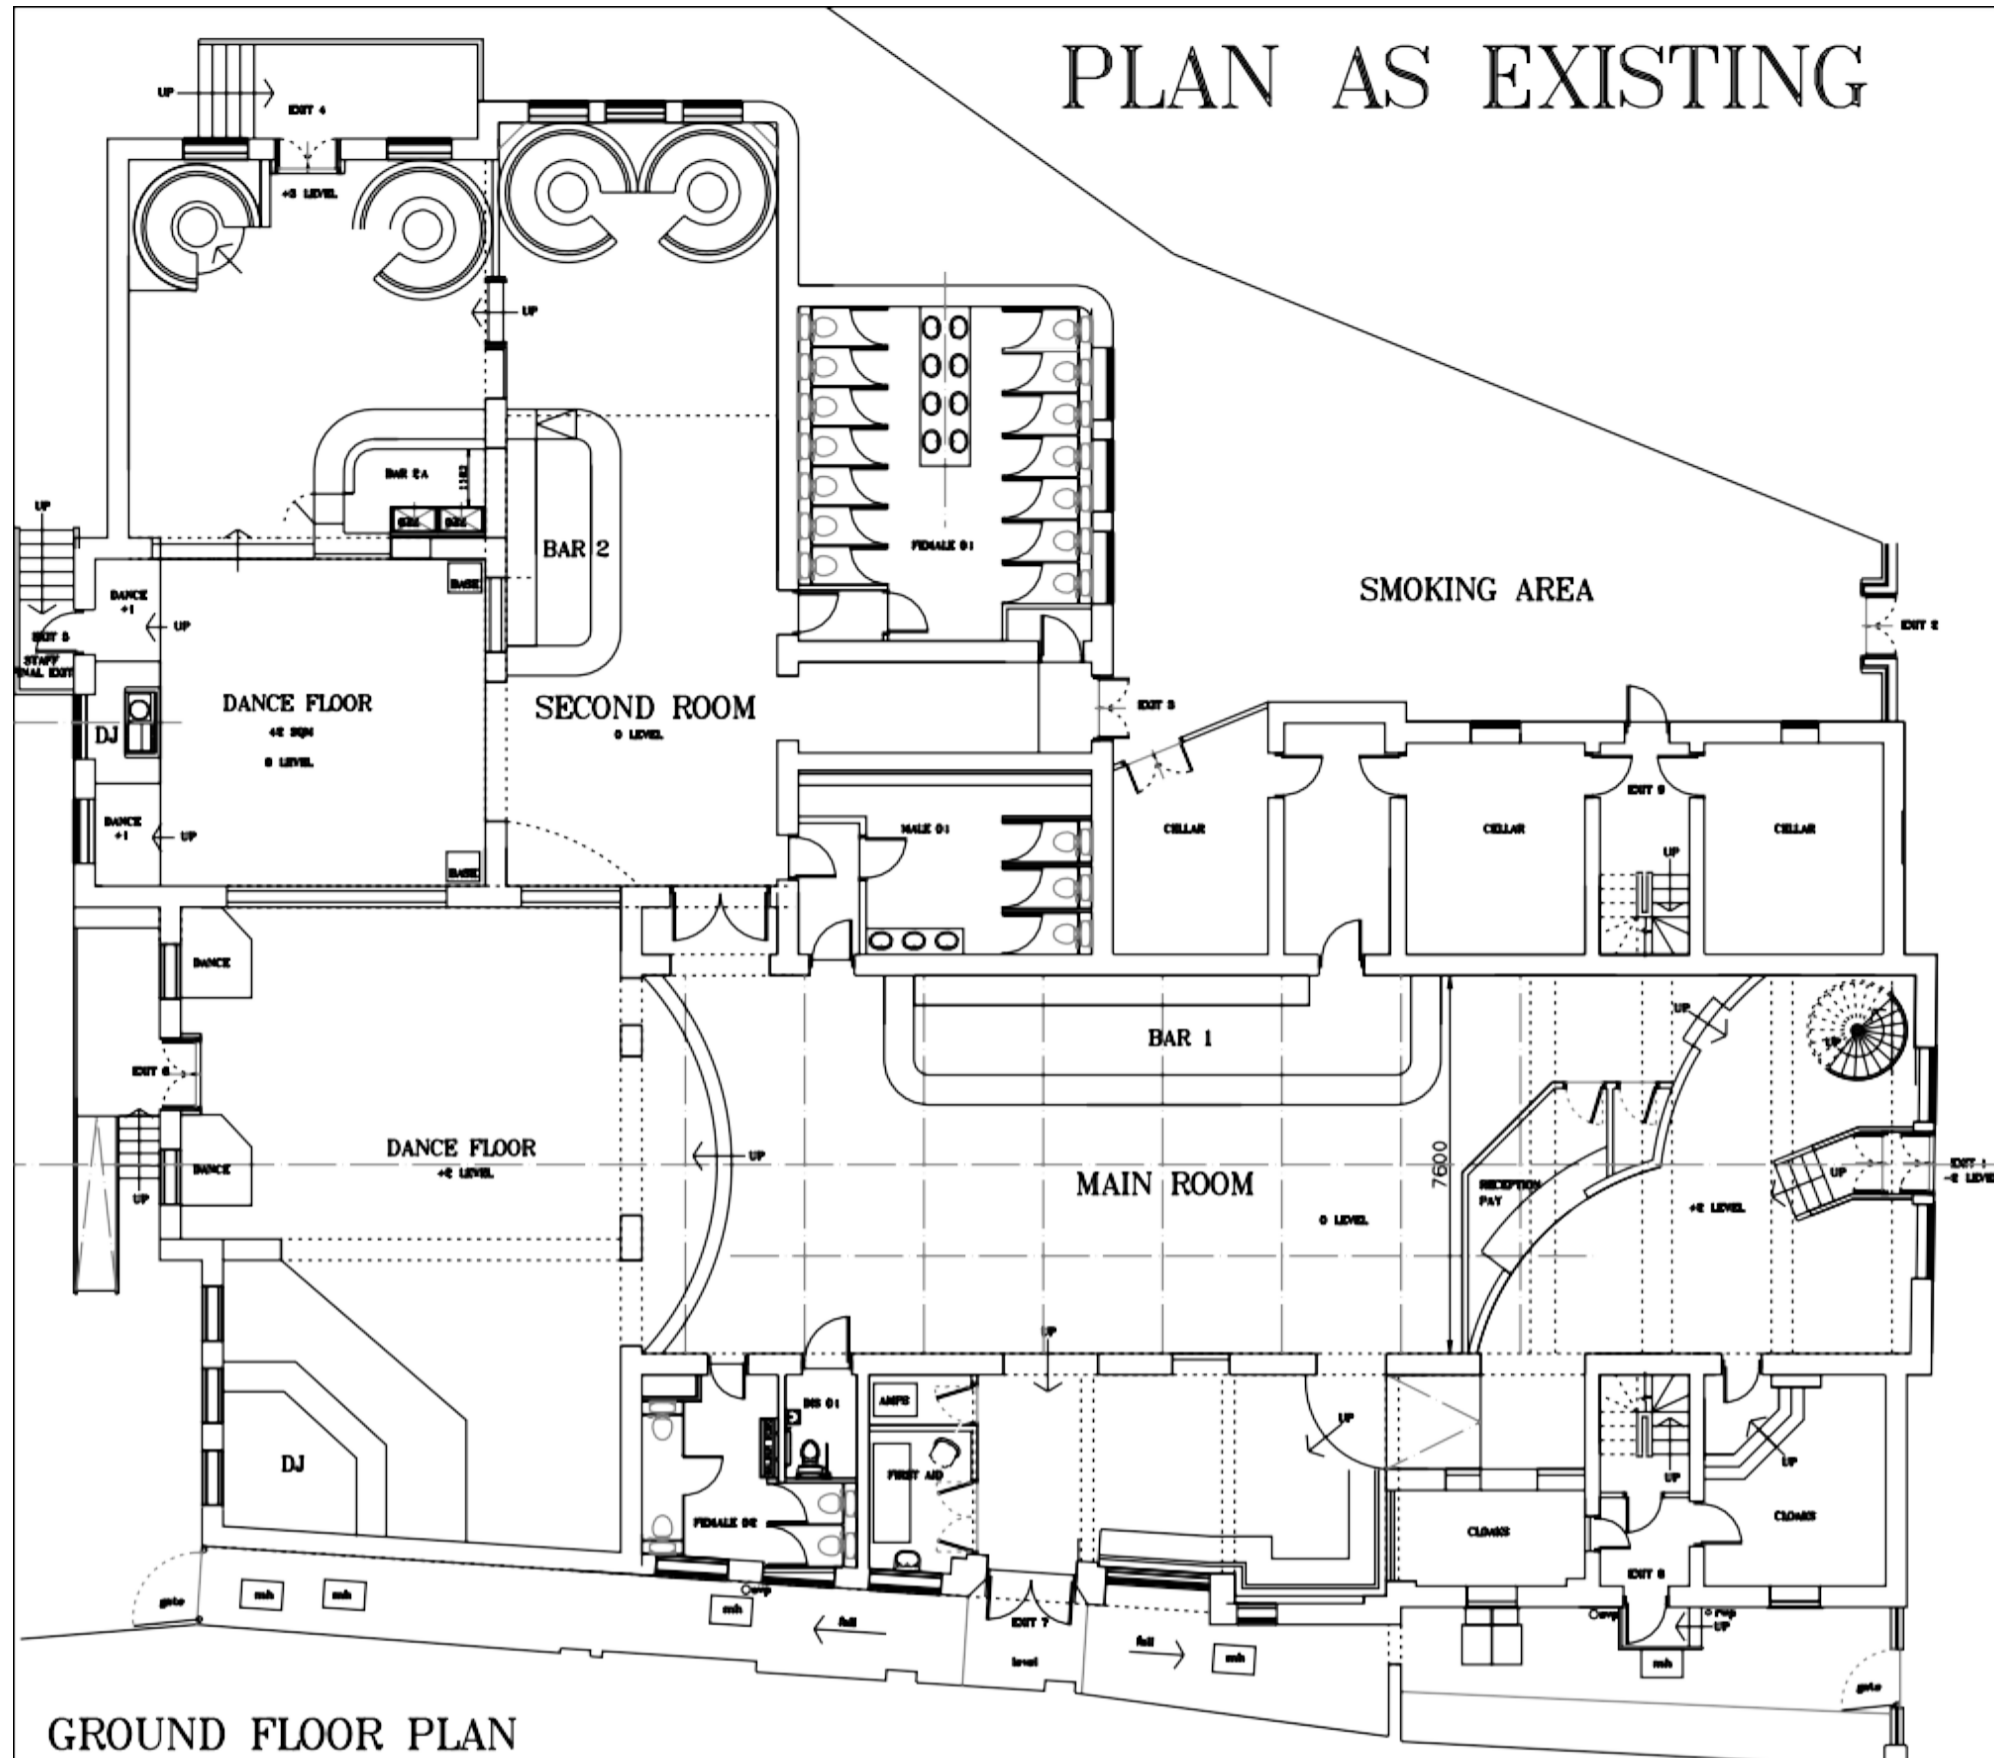


GROUND FLOOR PLAN

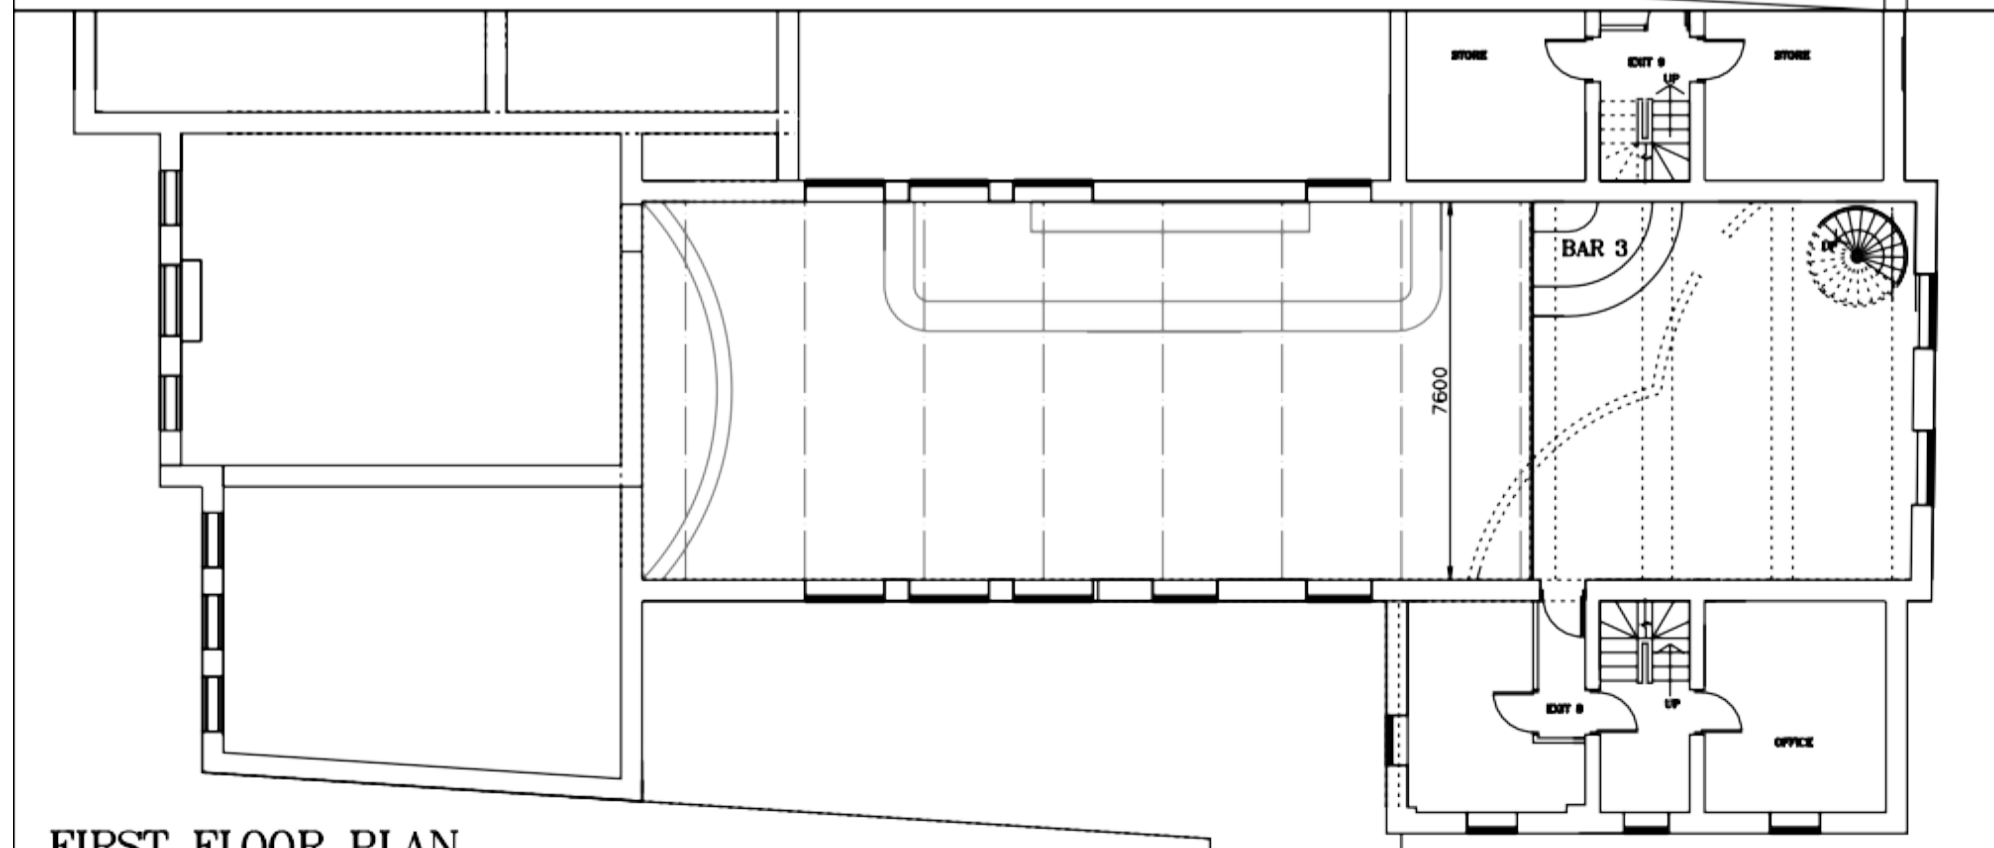


FIRST FLOOR PLAN

PLAN AS PROPOSED

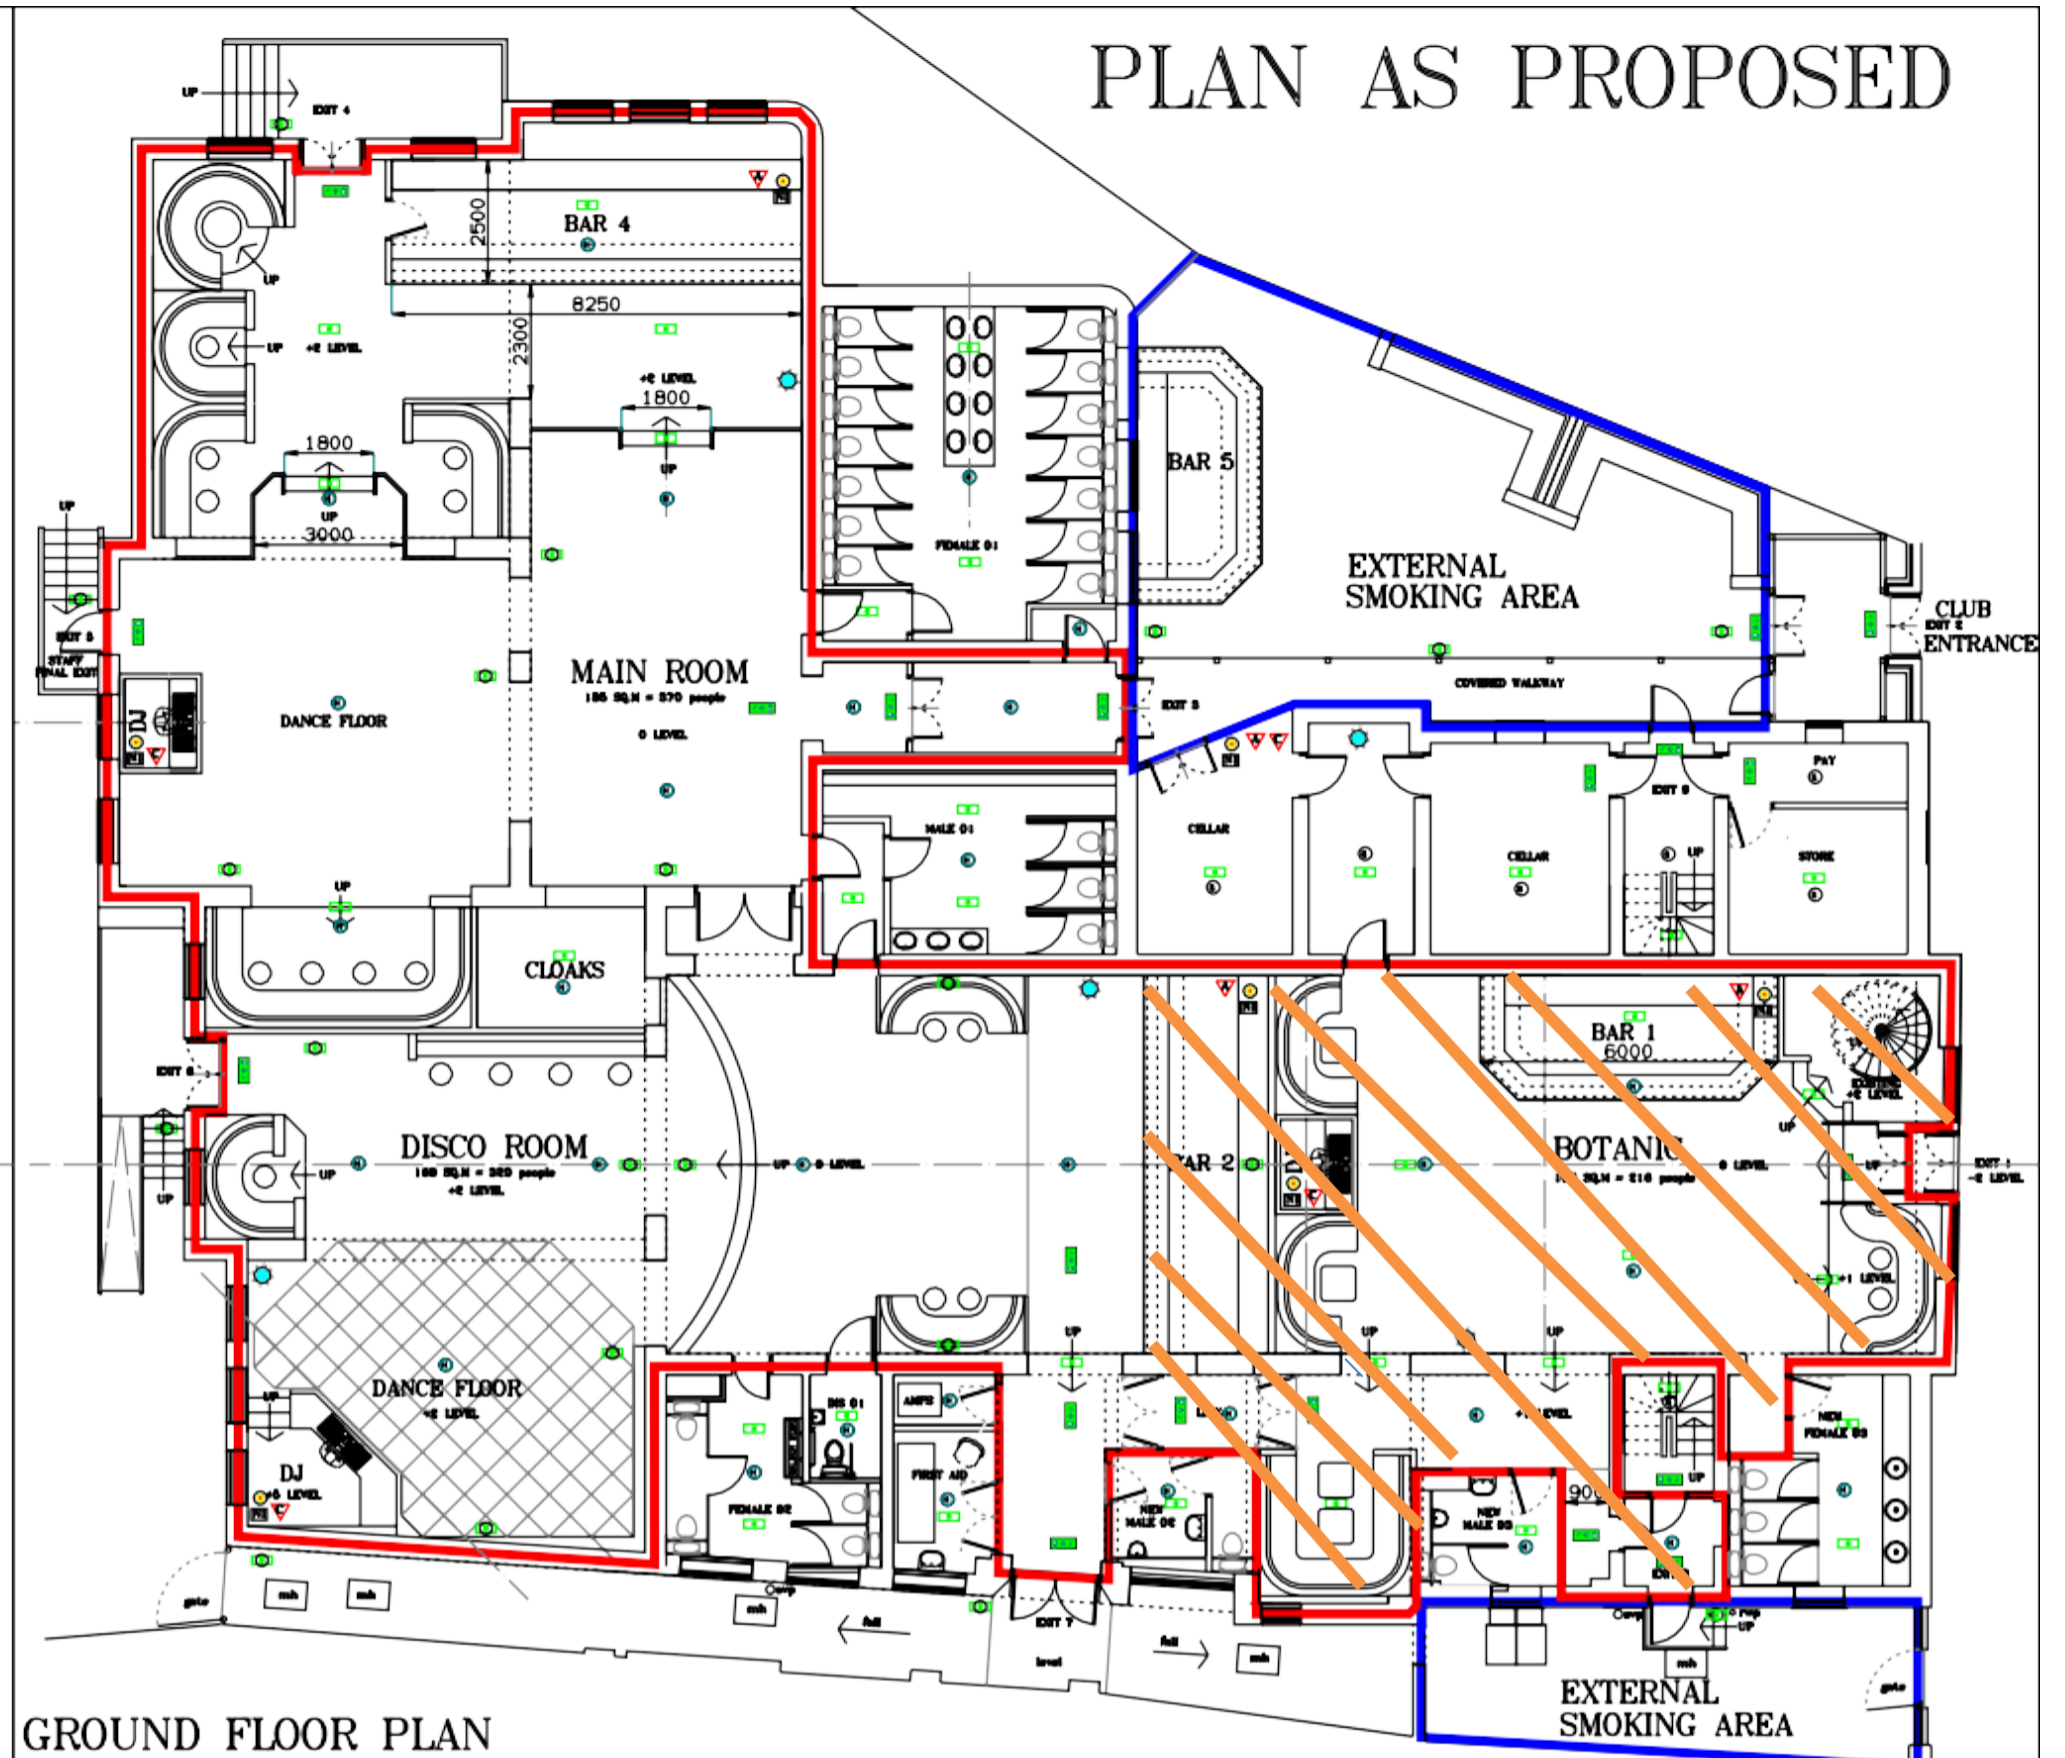

GROUND FLOOR PLAN

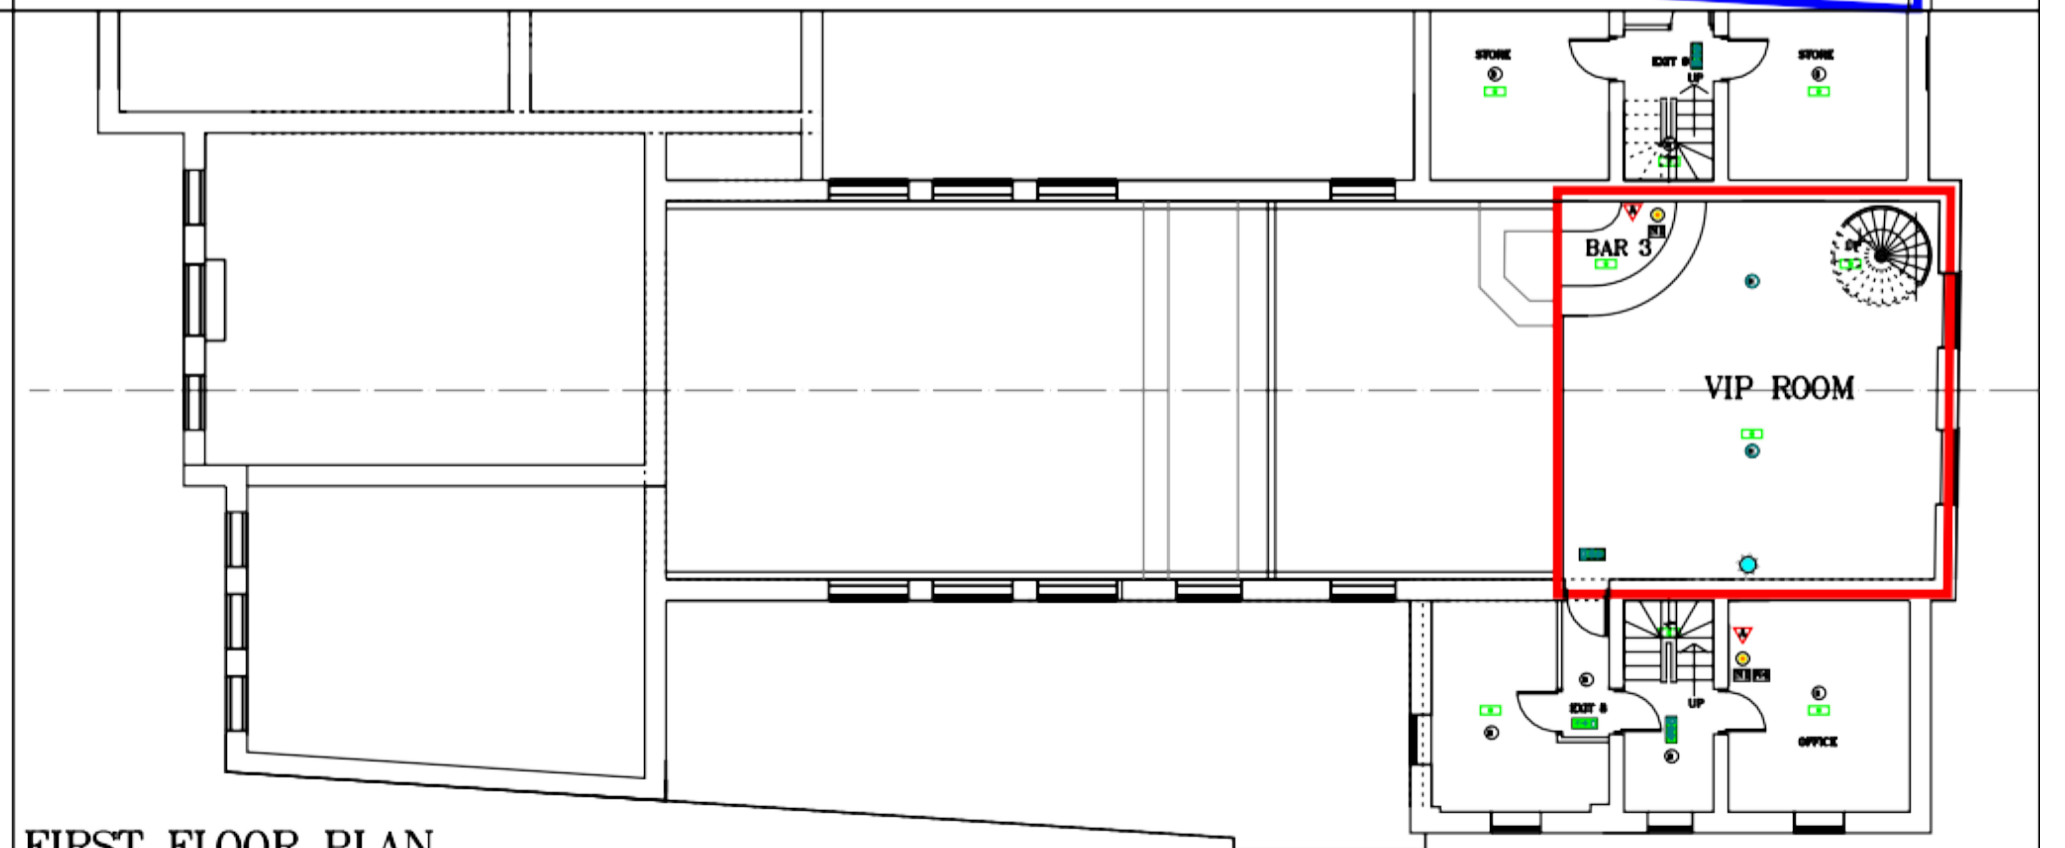

FIRST FLOOR PLAN

EMERGENCY LIGHTING www.edesign-solutions.co.uk EMERGENCY LIGHT 240V 5/10 W/100 BULBS/LED LIGHT BOX REF AC3000 PUBLIC AREA COMBINE OR WATT 20 DEGRADATIVE FITTING EMERGENCY SIGN 240V 5W BOX REF AC3004 PUBLIC AREA AC3010 EMERGENCY / CLEARWAY LIGHT 240V 5/10 W/100 TYPICAL SPOT WITH MULTI DIRECTIONAL BEAMS REF AC3007	FIRE EQUIPMENT 5kg WET-PILE/DRY FOAM EXTINGUISHER FIRE BLANKET 5kg CARBON DIOXIDE EXTINGUISHER	FIRE NOTICES 100mm SIGN BY EACH CALL POINT STAFF KITCHEN DUTY MANAGER	FIRE ALARM 100mm SIGN BY EACH CALL POINT HEAT DETECTOR MANUAL CALL POINT FIRE STROKE BREAKDOWN-LED VOID DETECTOR	FIRE ALARM PANEL FIRE ALARM REPEATER PANEL 50mm SIGN BY EACH INTERCOM POINT 50mm SIGN BY EACH INTERCOM POINT
--	--	--	--	---

 AREA BOUNDED BY THE BLUE LINE INDICATES LATE NIGHT REFRRESHMENT AND SALE OF ALCOHOL WITHIN THE EXTERNAL AREA
 AREA BOUNDED BY THE RED LINE INDICATES THE PROVISION OF REGULATED ENTERTAINMENT LATE NIGHT REFRRESHMENT AND SALE OF ALCOHOL

EDS 0148801704 0148801704 www.edesign-solutions.co.uk	Client: EPIC BARS & CLUBS Project: PLAY HEREFORD Title: LICENSING PLAN Drawn by: GRT Checked by: ... Project Manager: ... Date: SEP-23 Scale: 1:100 Drawing no: EH-23-301
--	--

© The Copyright in this drawing remains with Easy Design Solutions